






1 LOWER LEVEL FLOOR PLAN - POWER
 1/8" = 1'-0"

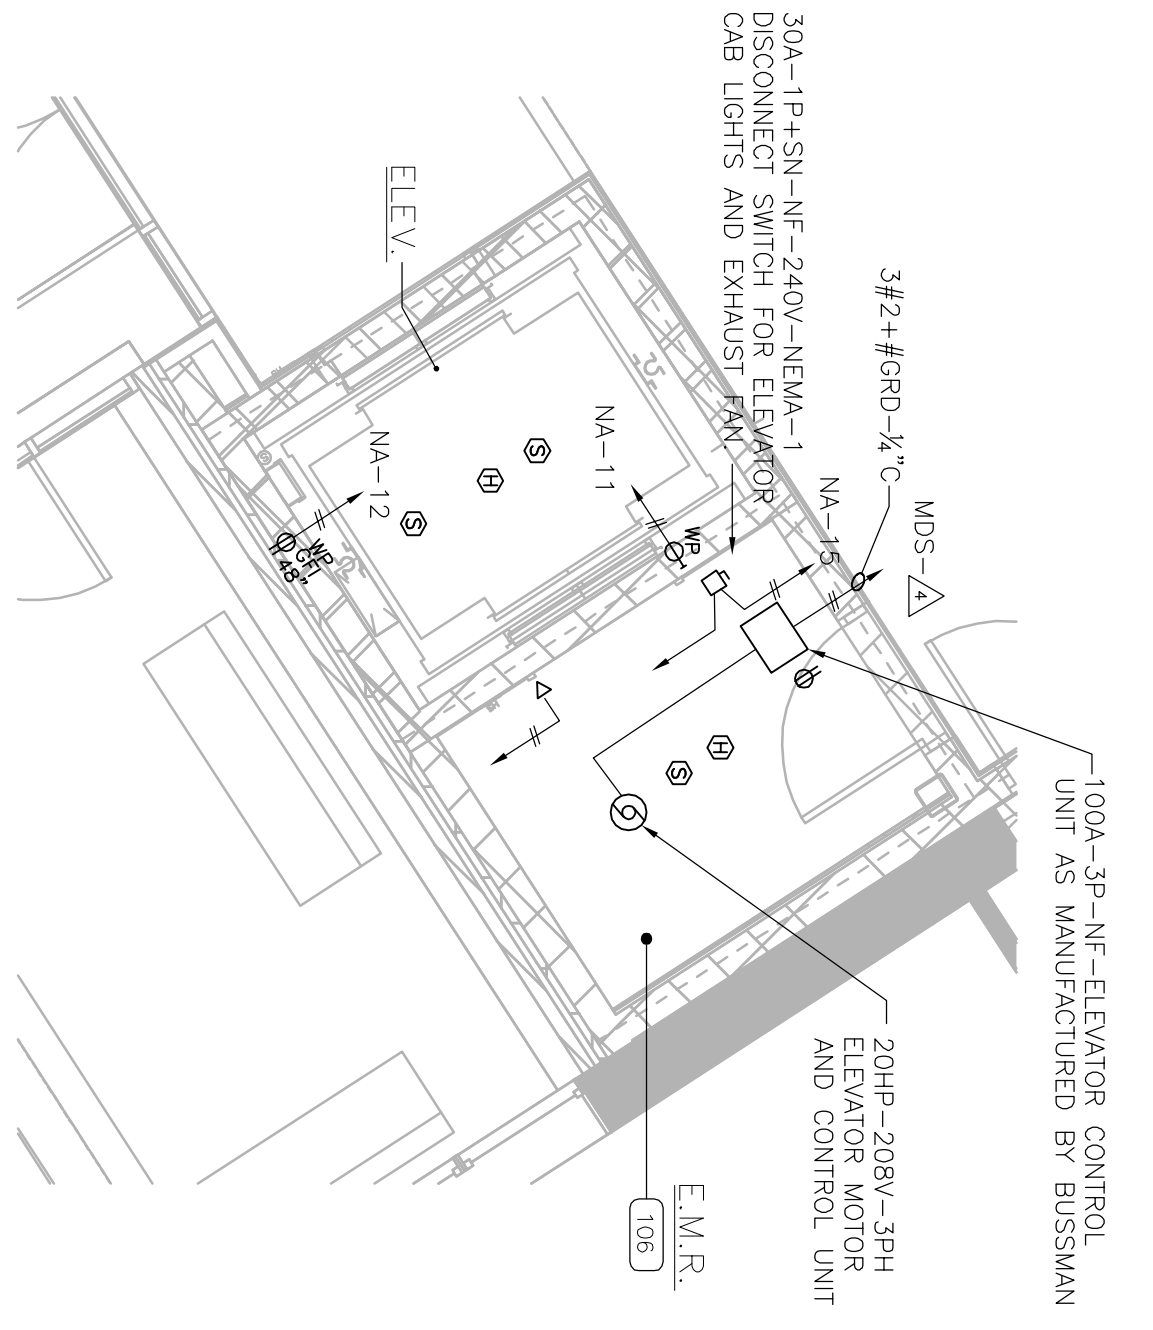


2 E.M.R./ELEV ROOMS - POWER
 1/4" = 1'-0"

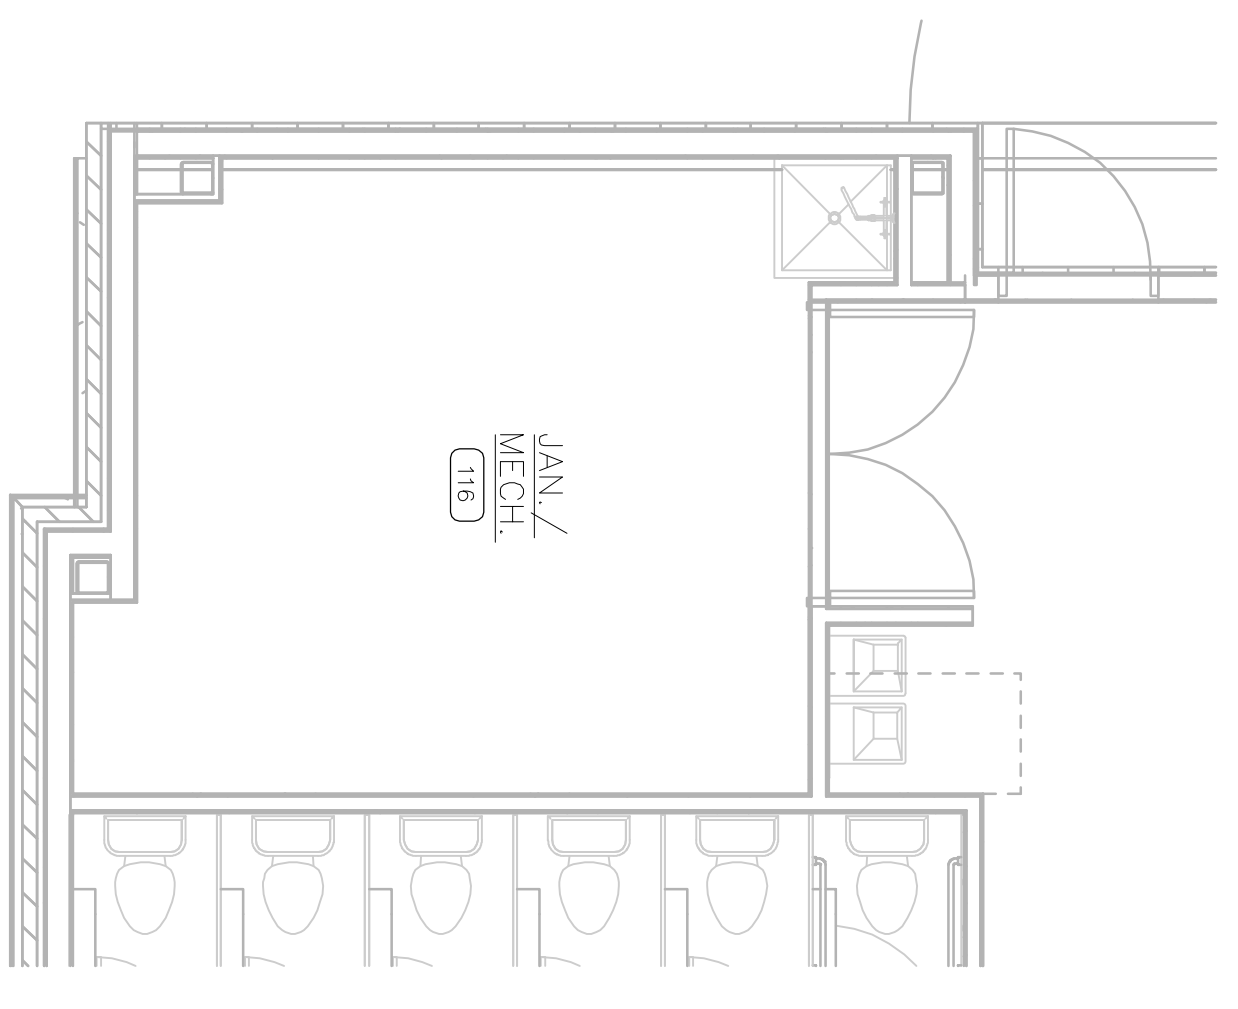

3 JAN./MECH. ROOM - POWER
 1/4" = 1'-0"

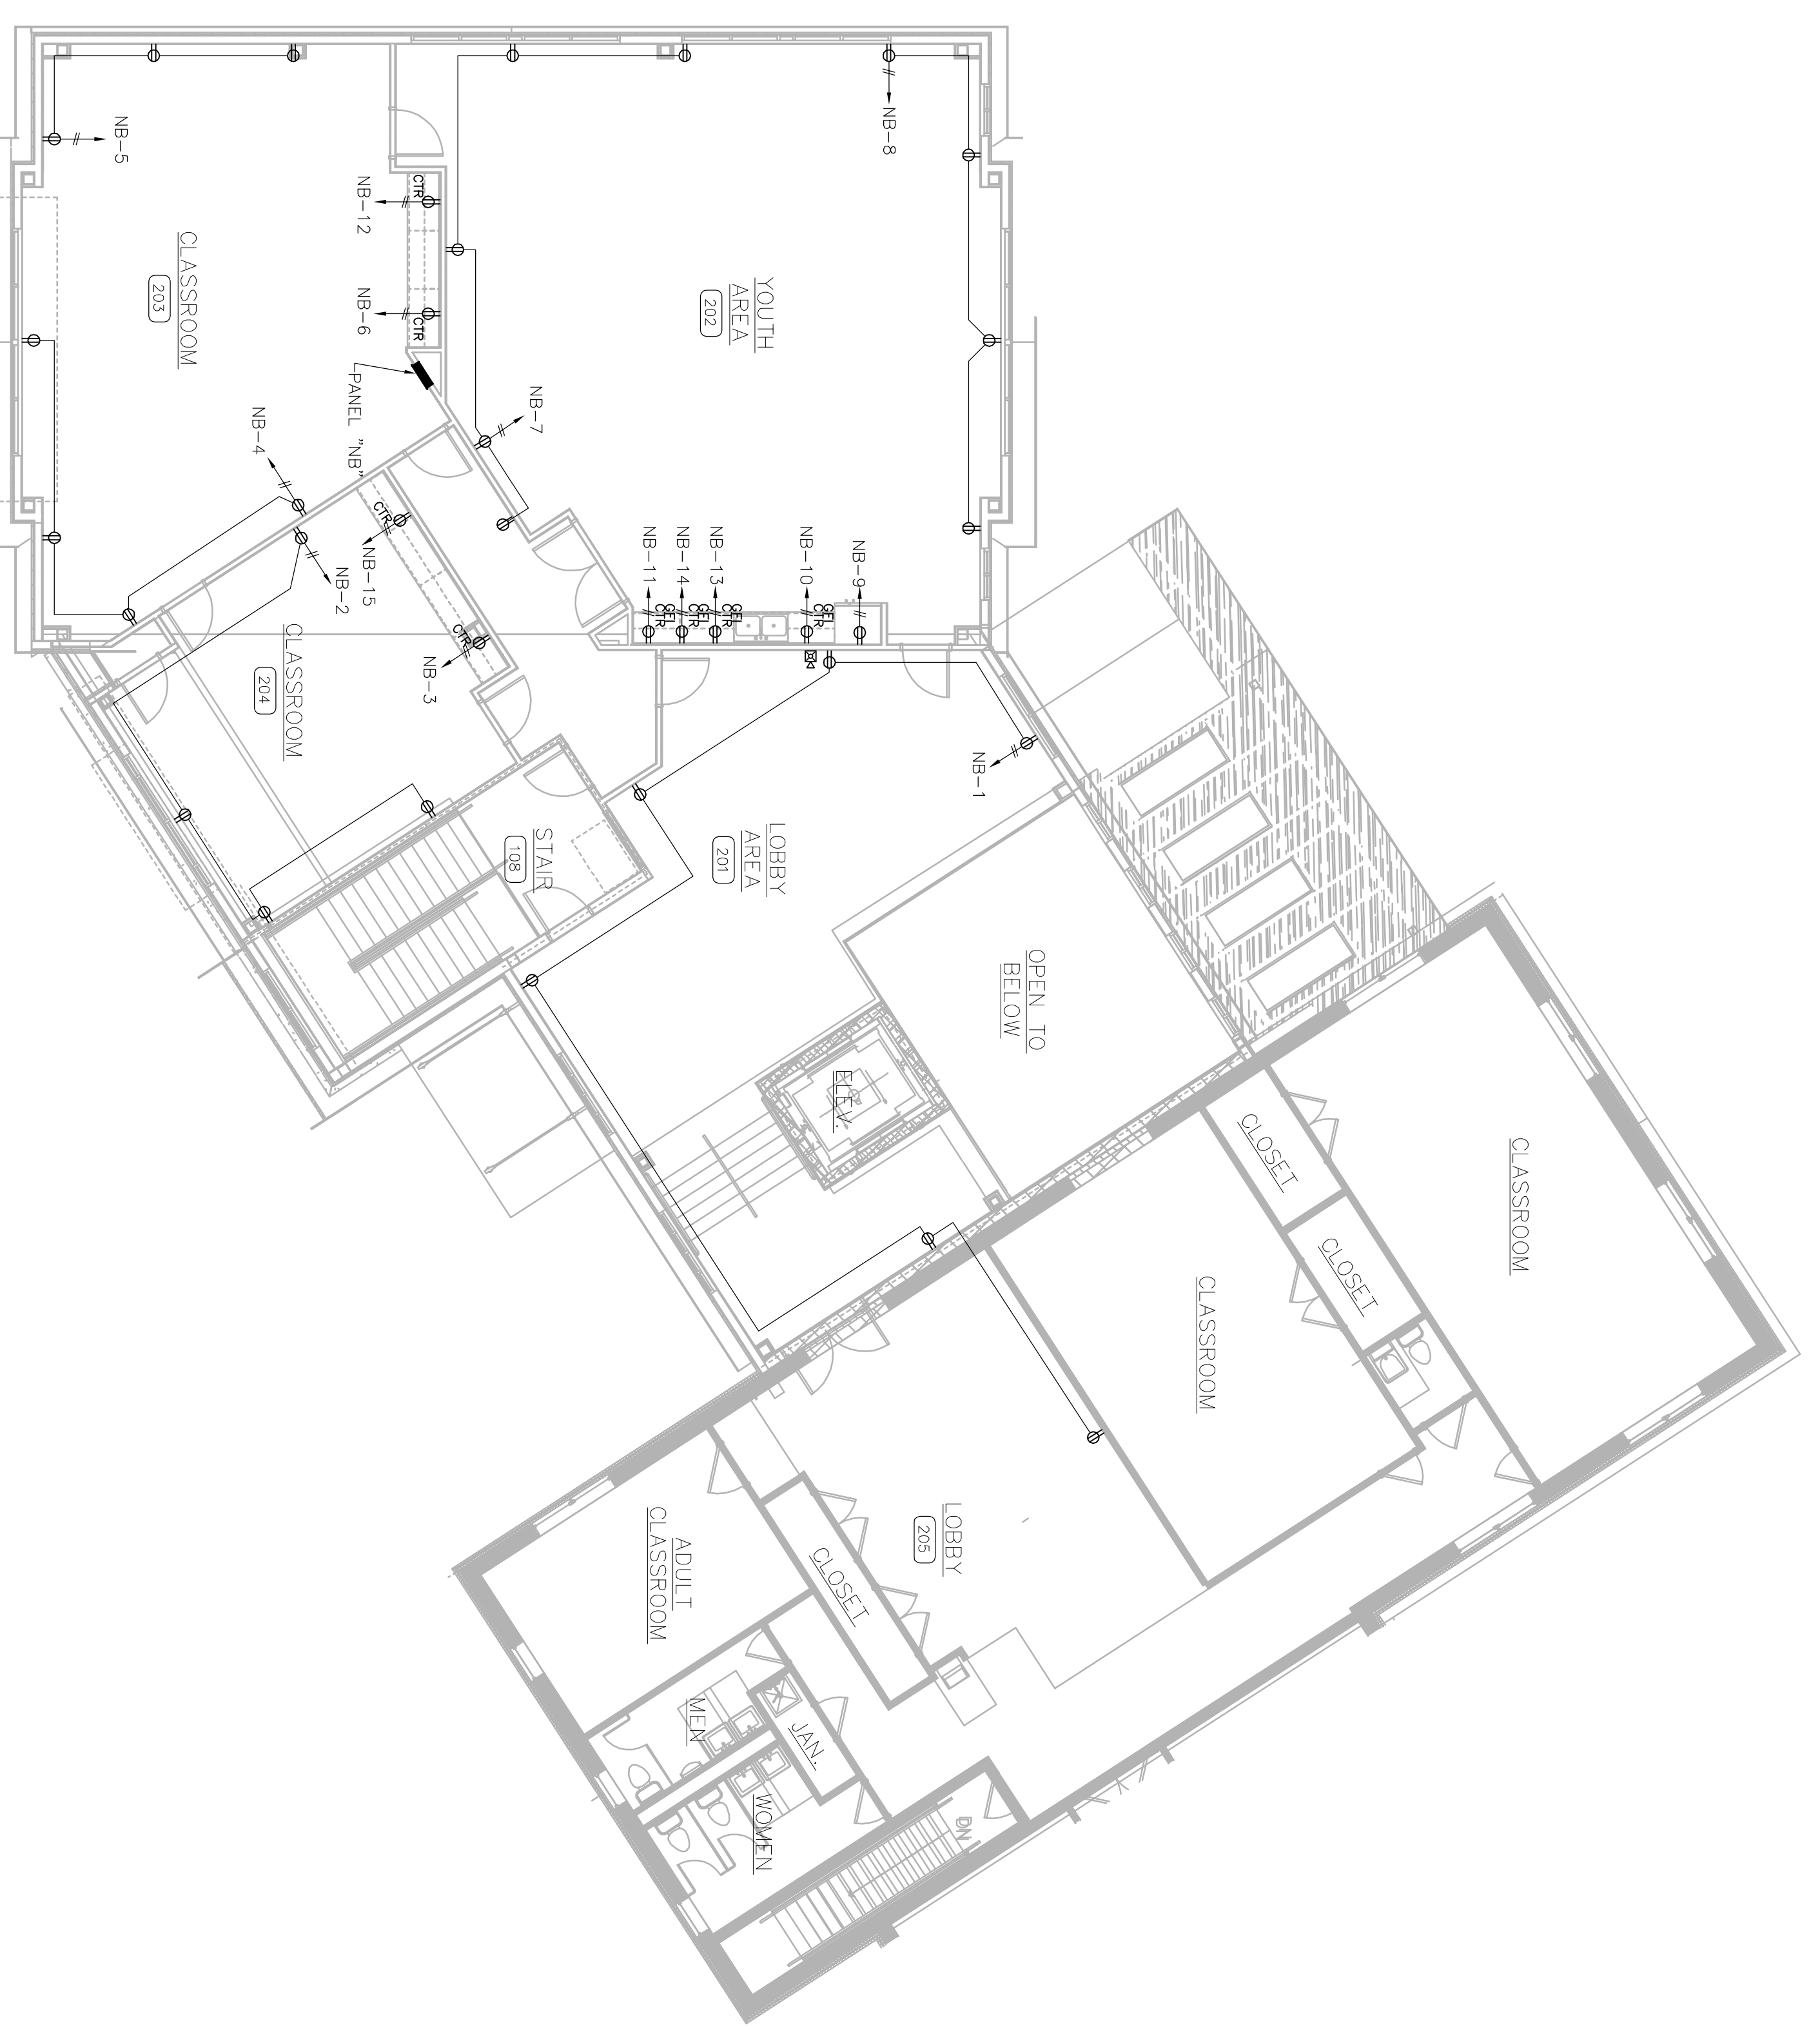

4 UPPER LEVEL FLOOR PLAN - POWER
 1/8" = 1'-0"

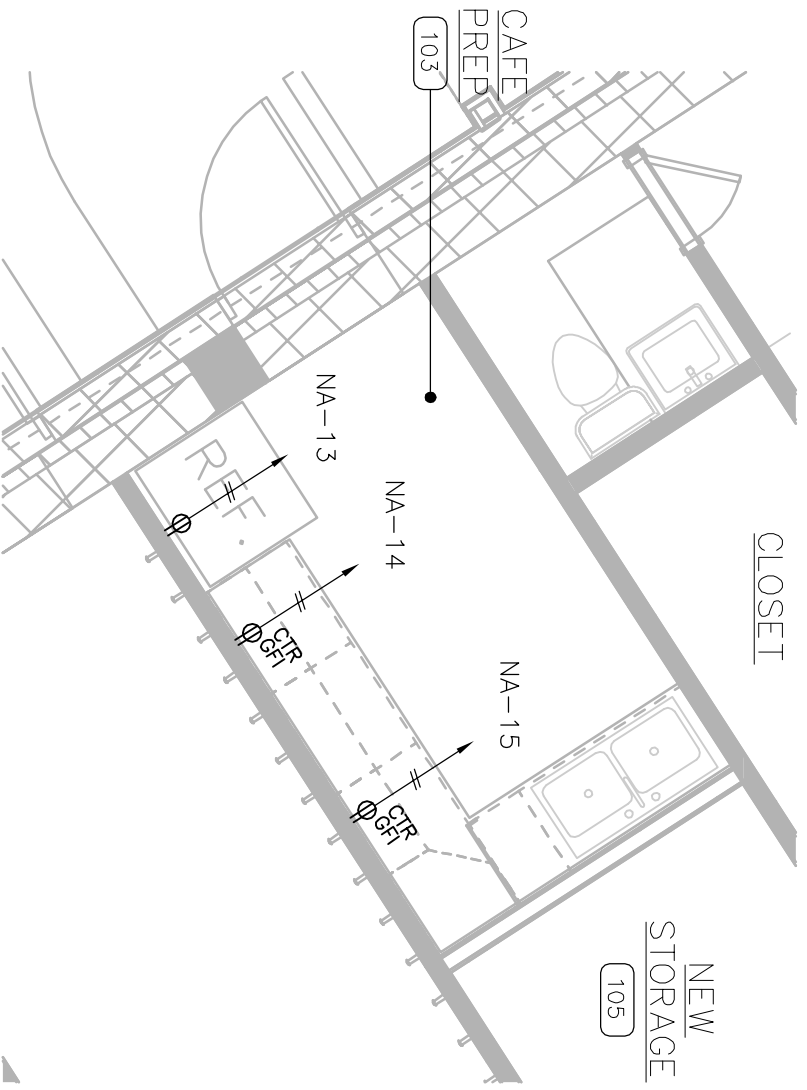

5 CAFE PREP ROOM - POWER
 1/4" = 1'-0"

WELCOME CENTER ADDITION
 FOR:
NICHOLS-BETHEL UMC
 1239 Murray Road
 Odenton, MD 21113

| NO. | REVISIONS DESCRIPTION | DATE |
|-----|-----------------------|------|
| | | |

PARAGON
 Engineering Services
 MECHANICAL • ELECTRICAL • PLUMBING
 ENERGY EFFICIENCY

2201 South Queen Street, York, PA 17402-4177 | 854-1014 (Fax) | 610-553-1268 | P:\0300\0399\0331-002-E102.dwg
 MERRILL HALLER CORNER BARTON MALOW GROUP
 3200 Highgate St., Suite 350, Abingdon, PA 18104 | 30 Linn Road, Suite 102, North East, MD 21081
 (410) 291-2000 • Fax (410) 331-4612 • Email: MPE@Paragon.com | (410) 491-1200 • Fax (410) 491-0222 • Email: MPE@Paragon.com

PREPARED FOR:
CORNERSTONE
 DESIGN ARCHITECTS
 48-50 W. CHESTNUT STREET, SUITE 400
 P.O. BOX 1798
 LANCASTER, PA 17608
 TEL: 717.435.1800 FAX: 717.435.1801

PROJECT PHASE:
 DETAILED DESIGN

| | |
|---------------------|------------|
| DRAWN BY | DATE |
| KJM | 2010.04.01 |
| DESIGNER | SCALE |
| RSF | As Noted |
| PROJECT NO. | |
| 07-0331-002 | |
| DRAWING NAME | |
| LOWER & UPPER LEVEL | |
| POWER | |
| SHEET NO. | |
| E102 | |