


JAN. MECH. RM
 1/4" = 1'-0"

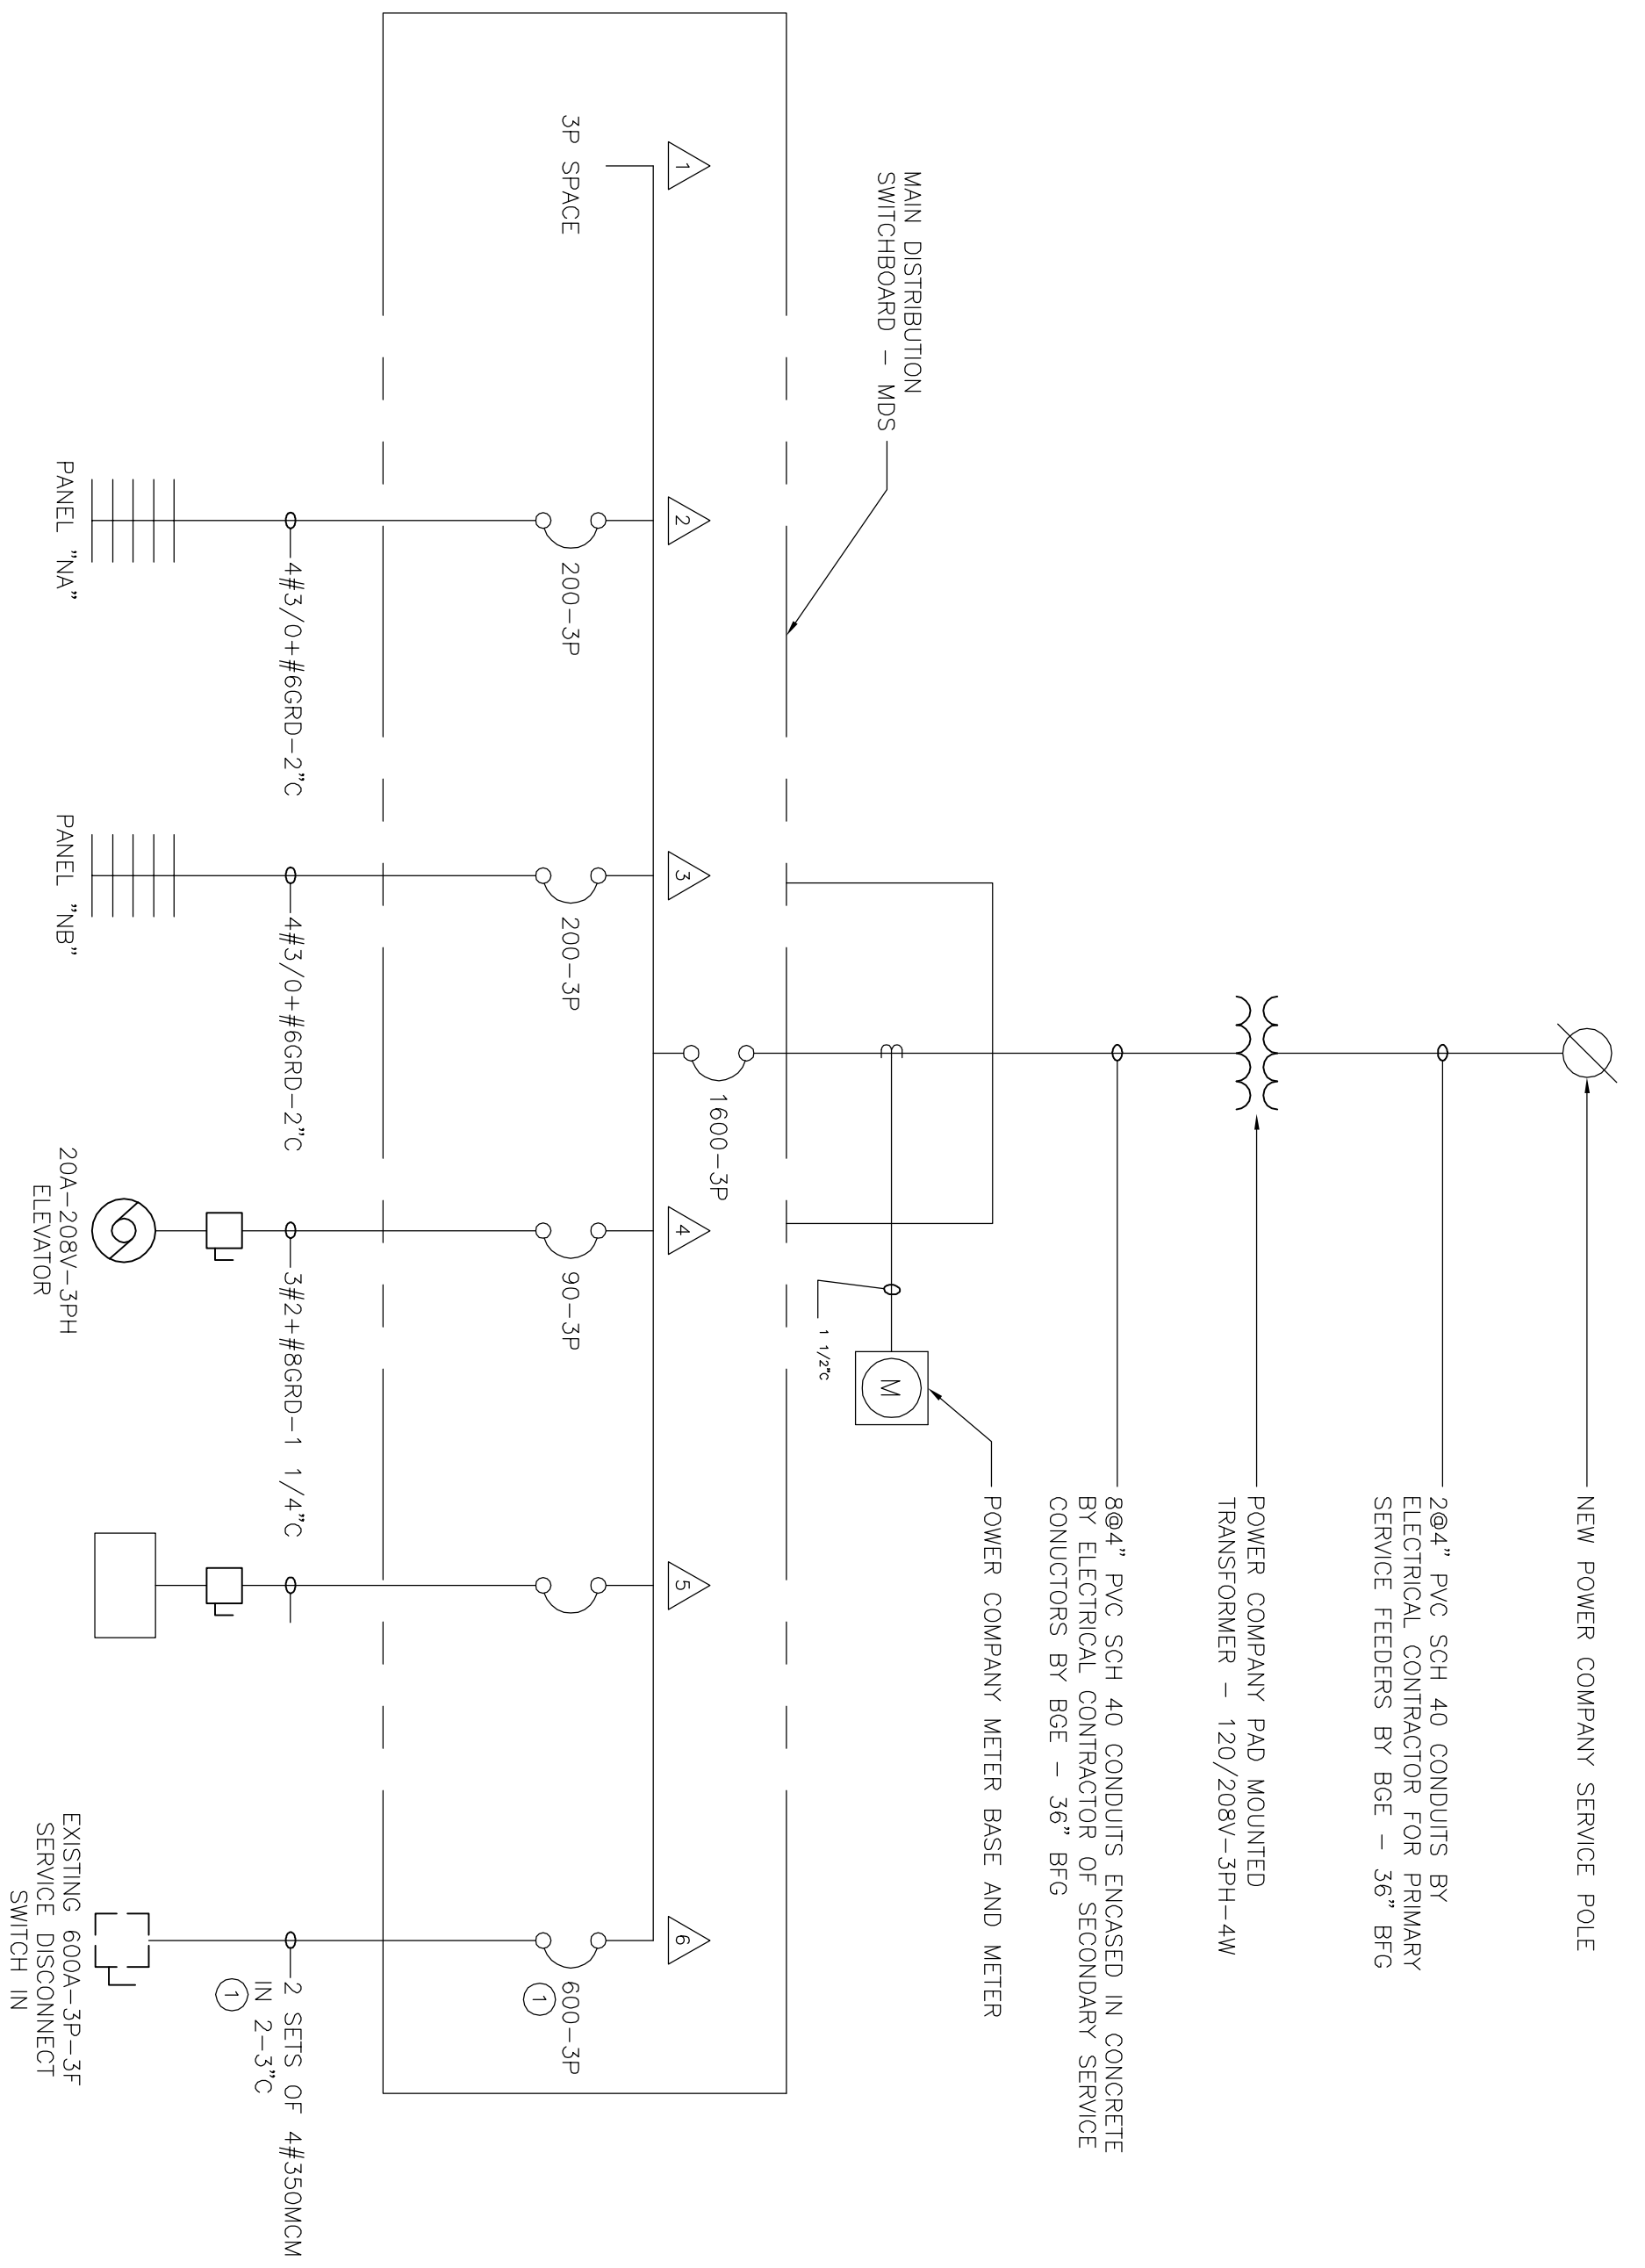

ONE LINE DIAGRAM
 NO SCALE

REVISIONS		
NO.	DESCRIPTION	DATE

PARAGON
 Engineering Services
 MECHANICAL - ELECTRICAL - PLUMBING
 CONSTRUCTION SERVICES

2291 South Queen Street, York, PA 17402-4177 | 84-1014 (Fax) (717) 664-5553 • Email: PFO@ParagonServices.org
 MIDDLETOWN OFFICE: 10000 HALLS CREEK, MIDDLETOWN, PA 17054
 BALTIMORE/MARYLAND OFFICE: 5020 Edgemoor St., Suite 340, Abertown, PA 18104 | 33 Linn Road, Suite 102, Rockville, MD, 21801
 (800) 294-2066 • Fax (717) 335-4662 • Email: MOW@ParagonServices.org | Fax (410) 641-0222 • Email: BOW@ParagonServices.org

PREPARED FOR:
CORNERSTONE
 DESIGN+ARCHITECTS
 48-50 W. CHESTNUT STREET, SUITE 400
 P.O. BOX 1788
 LANCASTER, PA 17608
 TEL: 717.435.1800 FAX: 717.435.1801

WELCOME CENTER ADDITION
 FOR:
NICHOLS-BETHEL UMC
 1239 Murray Road
 Odenton, MD 21113

PROJECT PHASE:	
DETAILED DESIGN	
DRAWN BY:	DATE:
XXX	2010.04.01
DESIGNER:	SCALE:
XXX	As Noted
PROJECT NO.:	
07-0331-002	
DRAWING NAME:	
ENLARGED PLANS	
SHEET NO.:	
E103	