


1 LOWER LEVEL FLOOR PLAN - HVAC
 1/8" = 1'-0"

NUMBERED NOTES: (X)
 1, 2 CONCENTRIC INTAKE & VENT UP THRU ROOF W/ ROOF CAP.

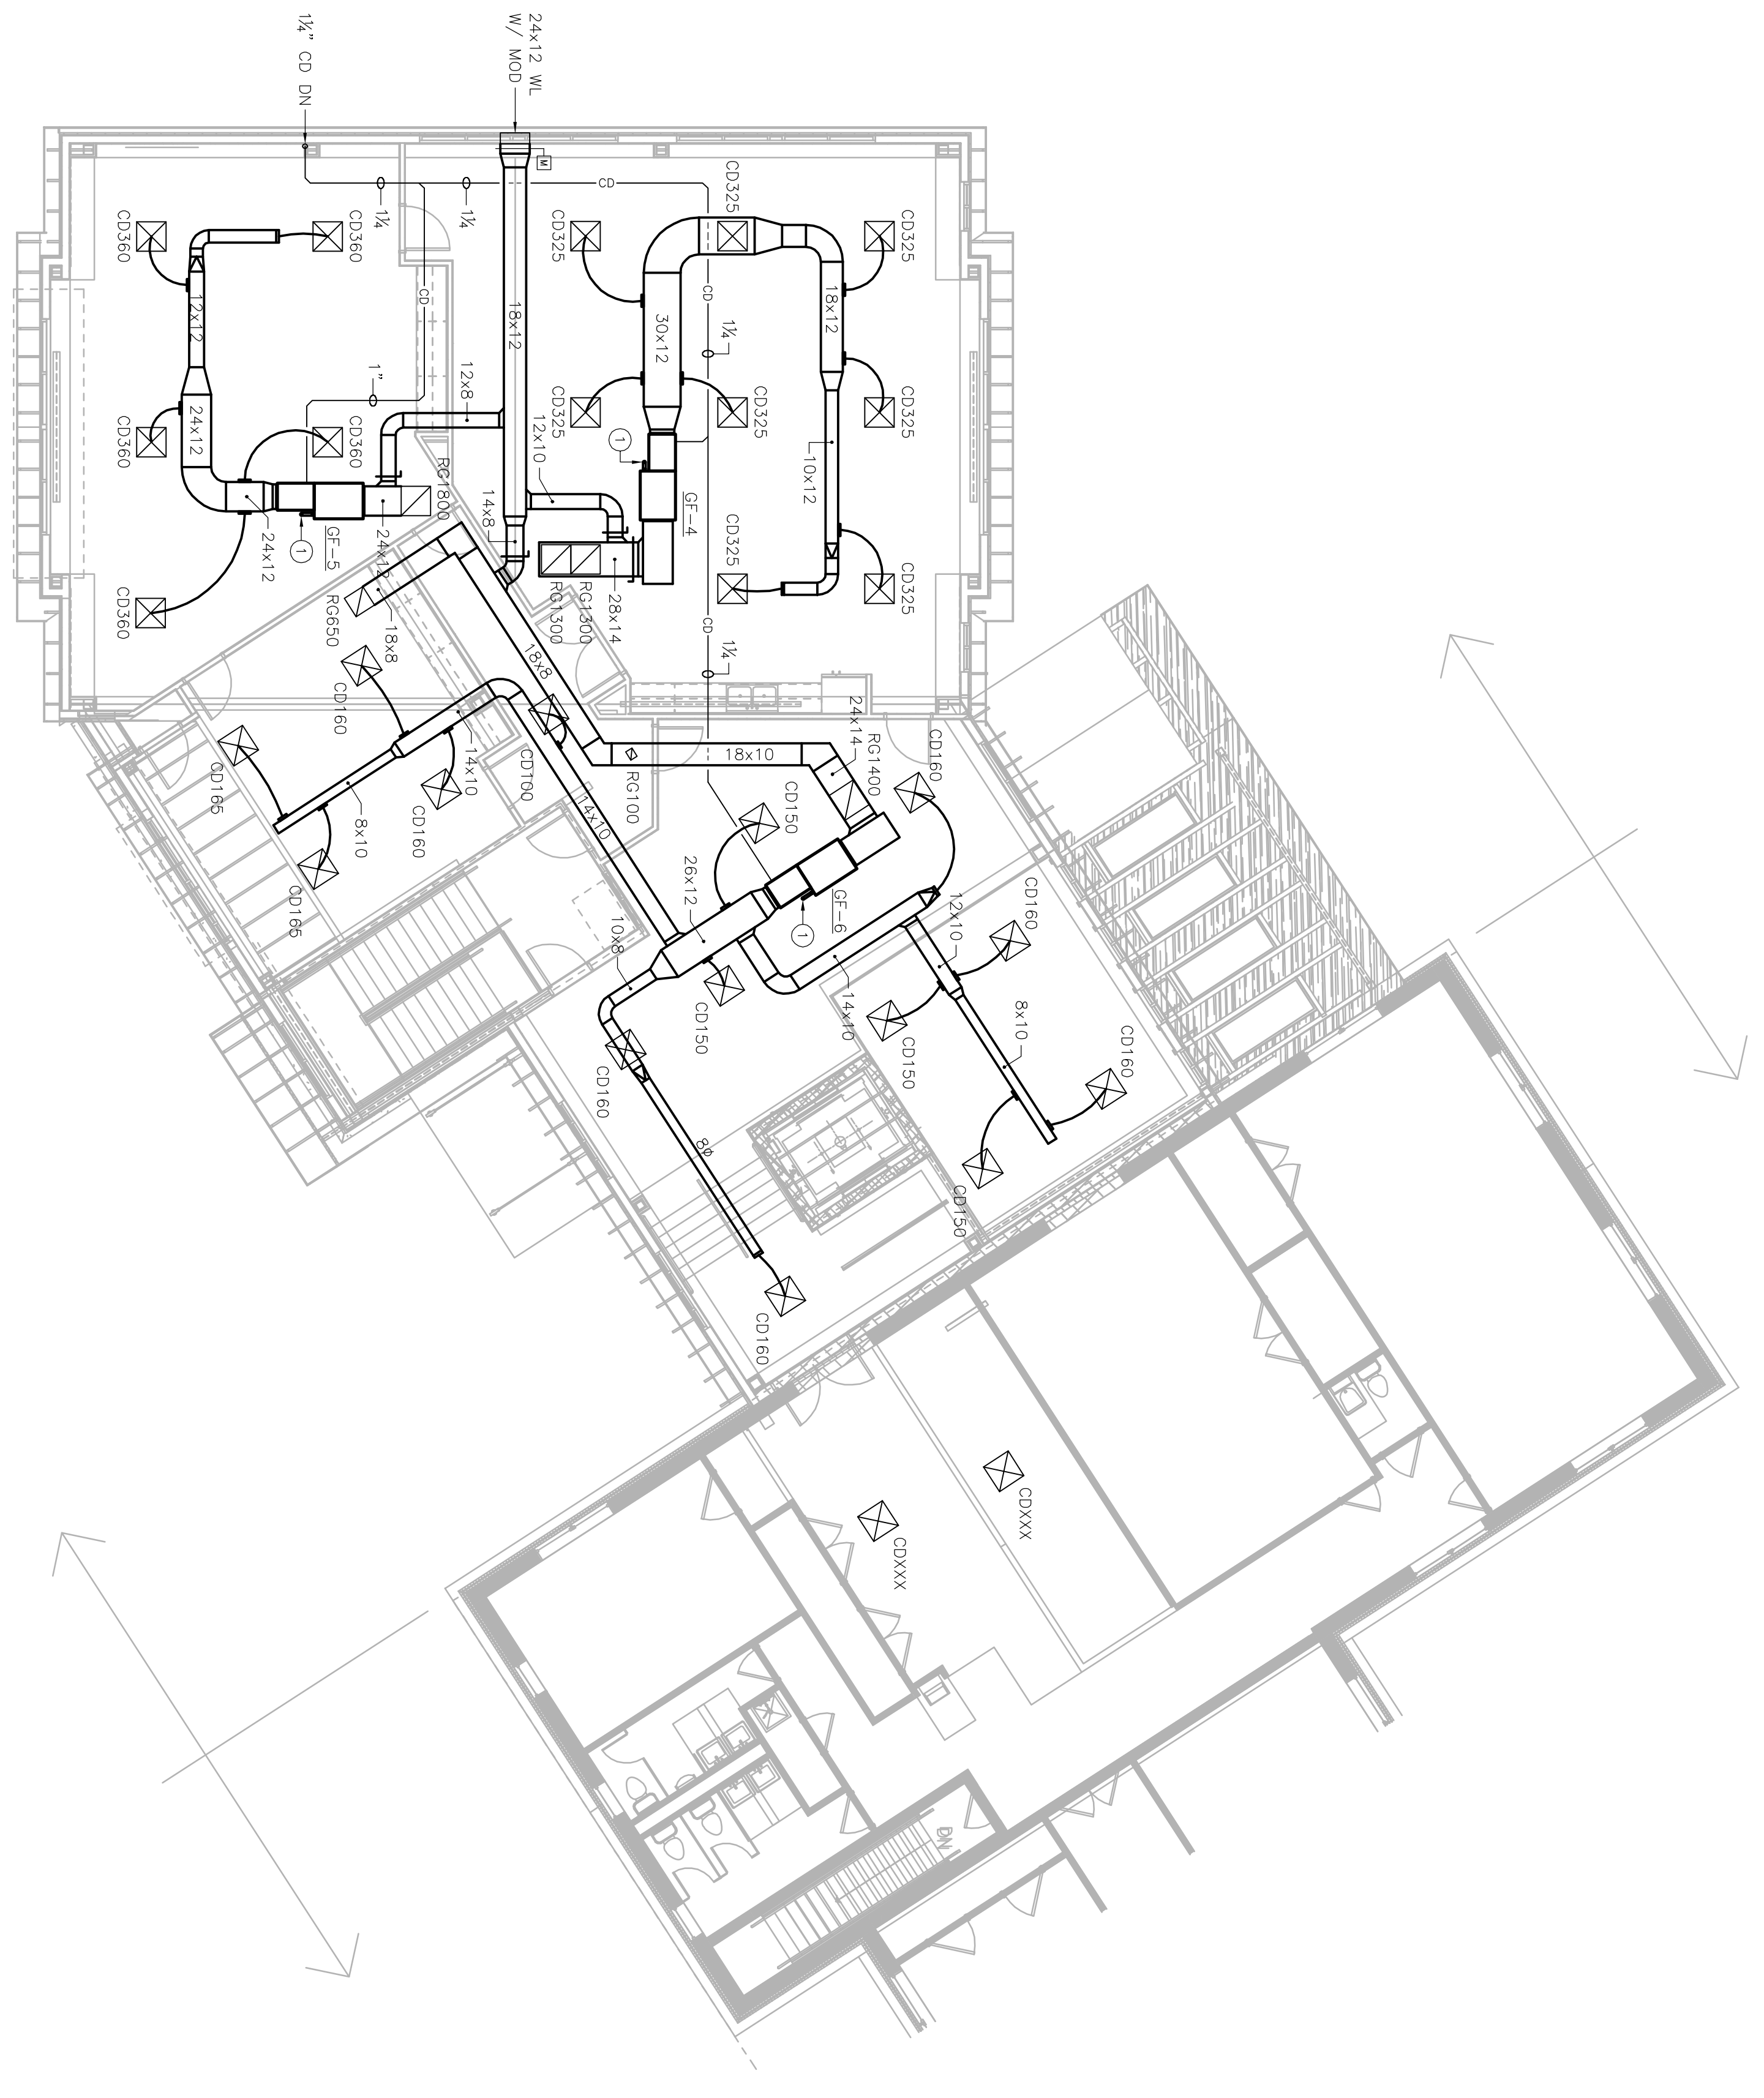

2 UPPER LEVEL FLOOR PLAN - HVAC
 1/8" = 1'-0"

PROJECT PHASE	
DETAILED DESIGN	
DRAWN BY	DATE
XXX	2010.04.01
DESIGNER	SCALE
XXX	As Noted
PROJECT NO.	
07-0331-002	
DRAWING NAME	
UPPER & LOWER LEVEL FLOOR PLANS - HVAC	
SHEET NO.	
M201	

WELCOME CENTER ADDITION
 FOR:
NICHOLS-BETHEL UMC
 1239 Murray Road
 Odenton, MD 21113

NO.	REVISIONS DESCRIPTION	DATE

PARAGON
 Engineering Services
 MECHANICAL • ELECTRICAL • PLUMBING
 DESIGN SERVICES

2201 South Queen Street, York, PA 17402-4177 | 84-1014 (PA) (717) 664-5553 • Fax: 84-1014
 1800 W. HALLS CREEK RD. | ALLENDALE, PA 18104 | 30 LANE ROAD, SUITE 102 | ROCKY HILL, MD 21151
 (410) 281-2000 • Fax (410) 281-4600 • Email: MWP@Paragon.com | (410) 671-0200 • Email: MWP@Paragon.com

PREPARED FOR:

CORNERSTONE
 DESIGN ARCHITECTS
 48-50 W. CHESTNUT STREET, SUITE 400
 P.O. BOX 1788
 LANCASTER, PA 17608
 TEL: 717.435.1800 FAX: 717.435.1801